
 


LEGEND

- ODOT
- PRIVATE
- CITY

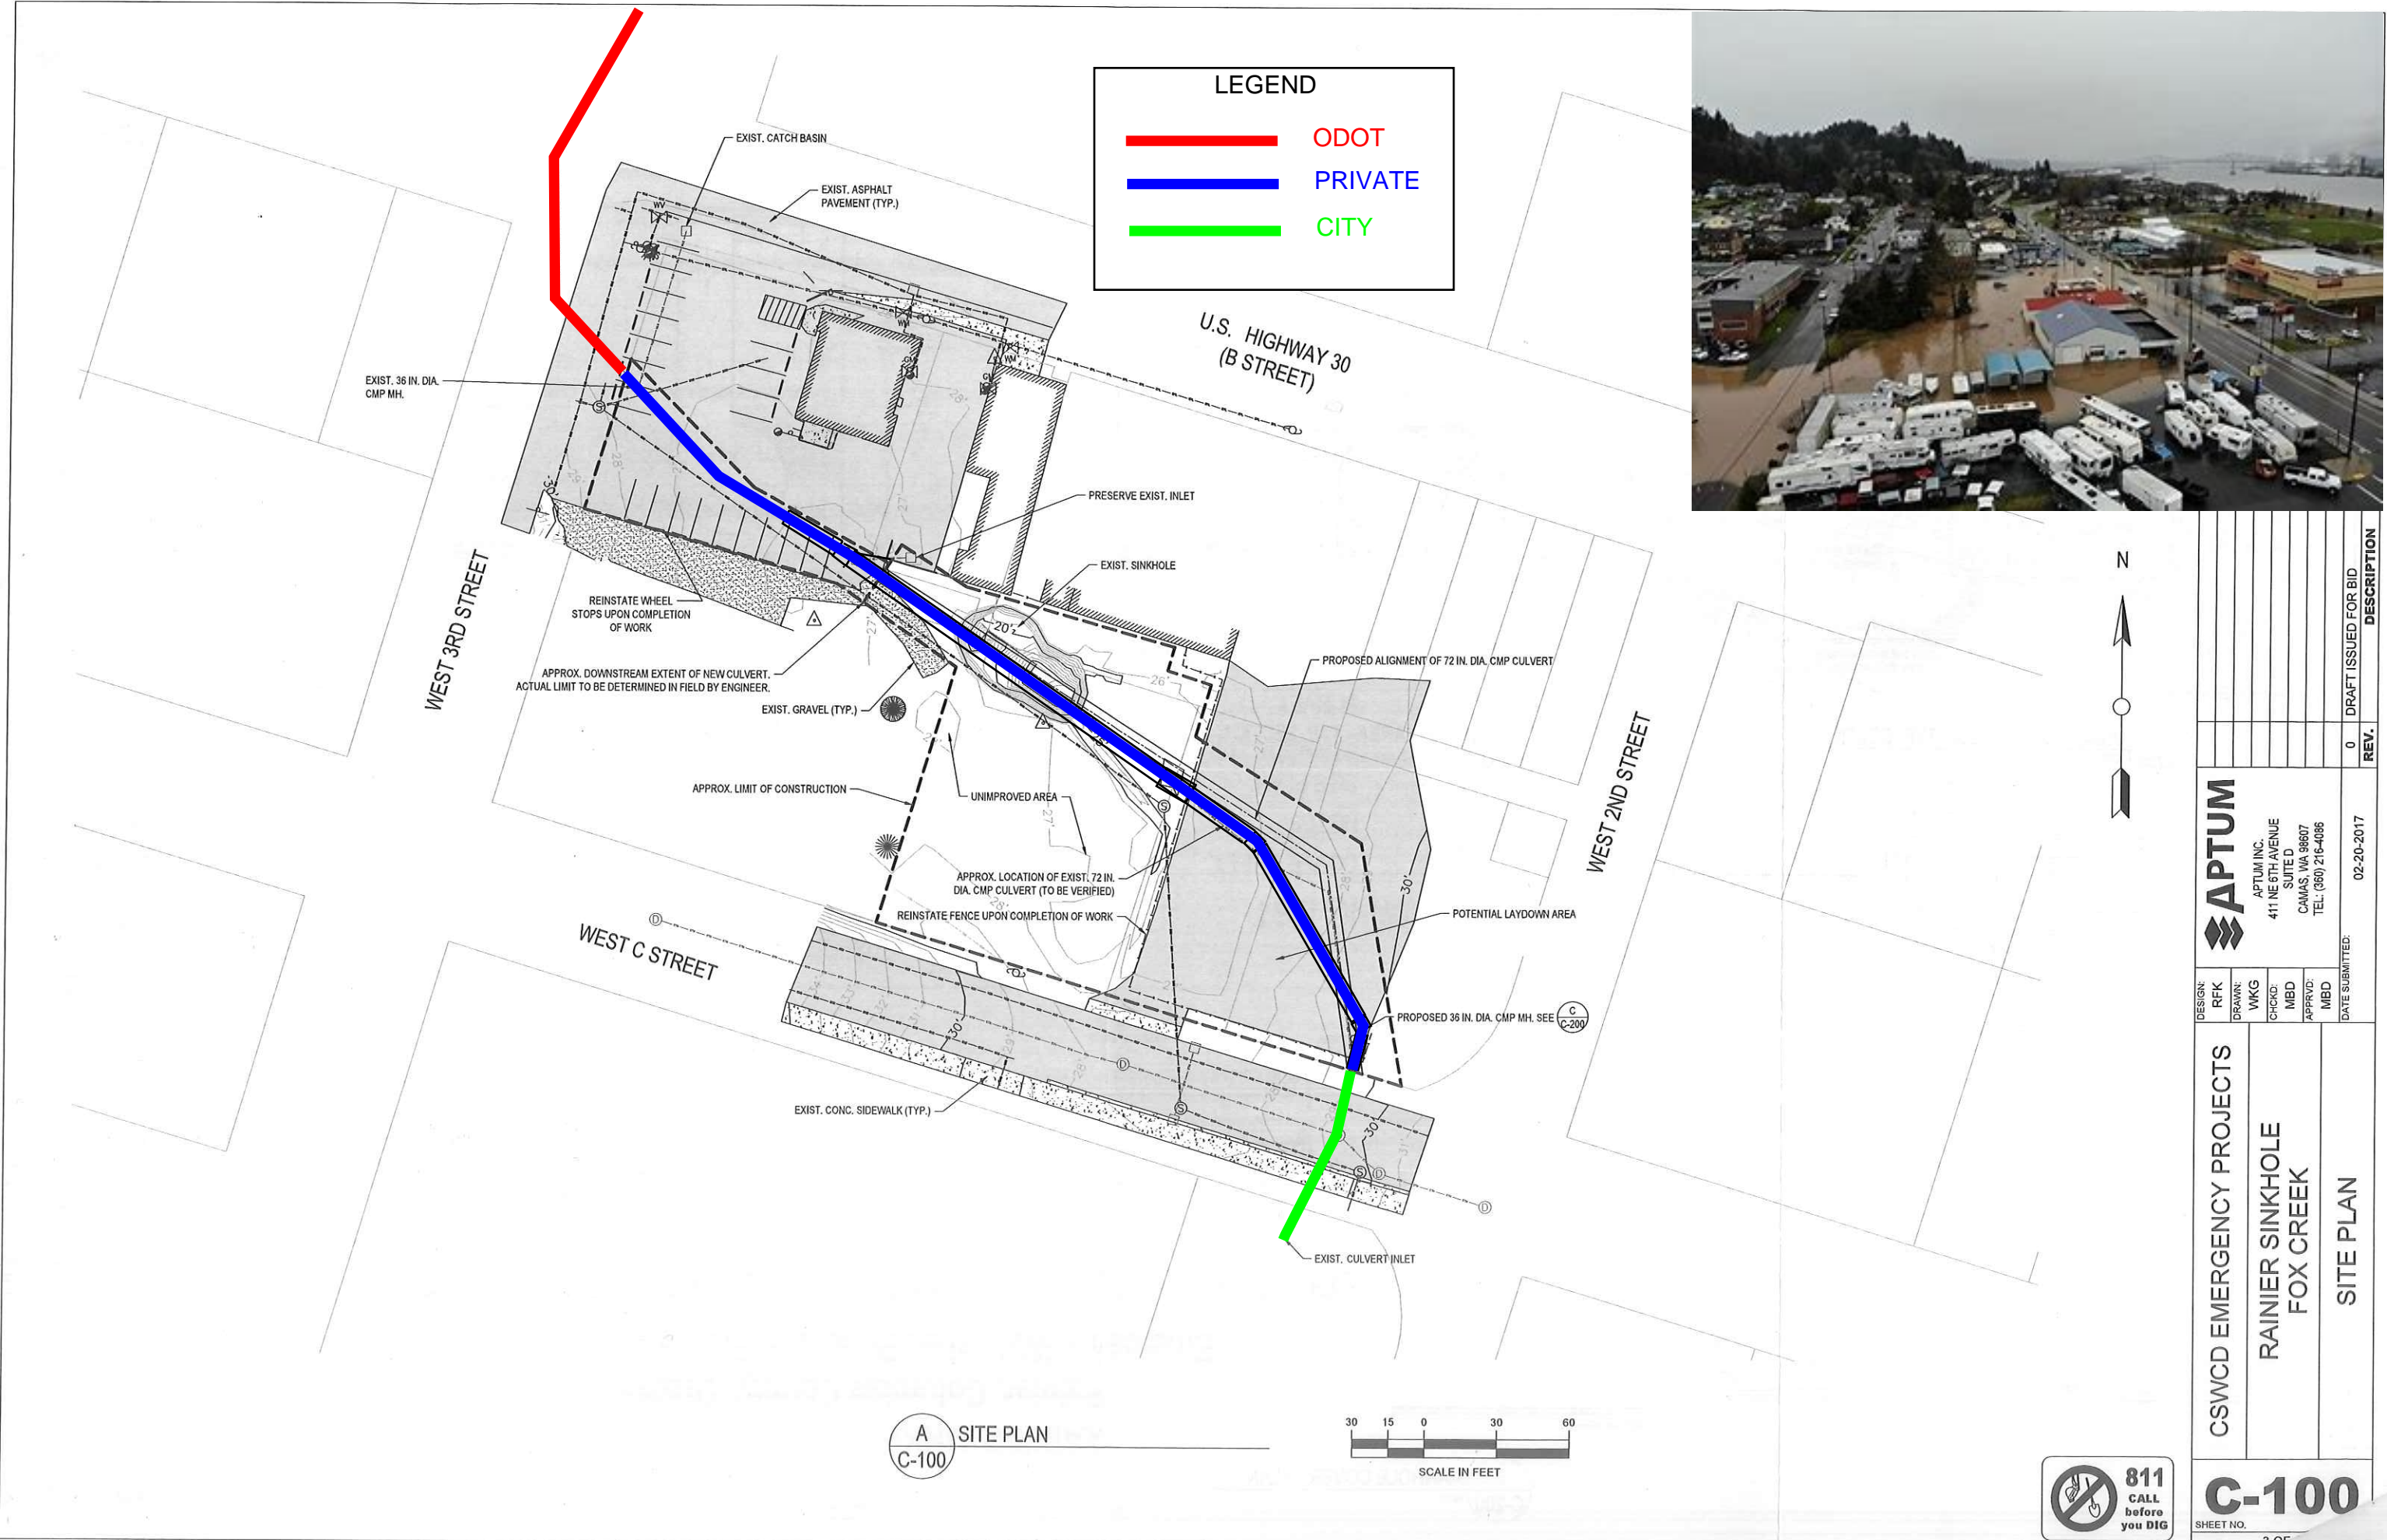

A SITE PLAN
C-100



| | | | | | | | | | | | |
|--------------------------|--|------------------|--|-------------------|--|-------------------------|--|----------------------------|--|----------------------|--|
| DESIGN: RFK | | DRAWN: WKG | | CHECKED: MBD | | APPROVED: MBD | | DATE SUBMITTED: 02-20-2017 | | DRAFT ISSUED FOR BID | |
| CSWCD EMERGENCY PROJECTS | | RAINIER SINKHOLE | | FOX CREEK | | SITE PLAN | | REV. | | DESCRIPTION | |
| APTUM | | APTUM INC. | | 411 NE 6TH AVENUE | | SUITE D | | CAMAS, WA 98607 | | TEL: (360) 216-4086 | |
| C-100 | | SHEET NO. | | 3 OF | | 811 CALL before you DIG | | | | | |